

1 SOUTHEAST ELEVATION
SCALE: 3/16" = 1'-0"




2 NORTHWEST ELEVATION
SCALE: 3/16" = 1'-0"

WALL AREA & GLAZING AREA:
WALL AREA BETWEEN 3'-0" = 580 SQ FT
25% OF WALL AREA = 145 SQ FT
TOTAL GLAZING SQ FT = 150 SQ FT



3 NORTHEAST ELEVATION
SCALE: 3/16" = 1'-0"

WALL AREA & GLAZING AREA:
WALL AREA BETWEEN 3'-0" = 230 SQ FT
25% OF WALL AREA = 57.5 SQ FT
TOTAL GLAZING SQ FT = 60 SQ FT

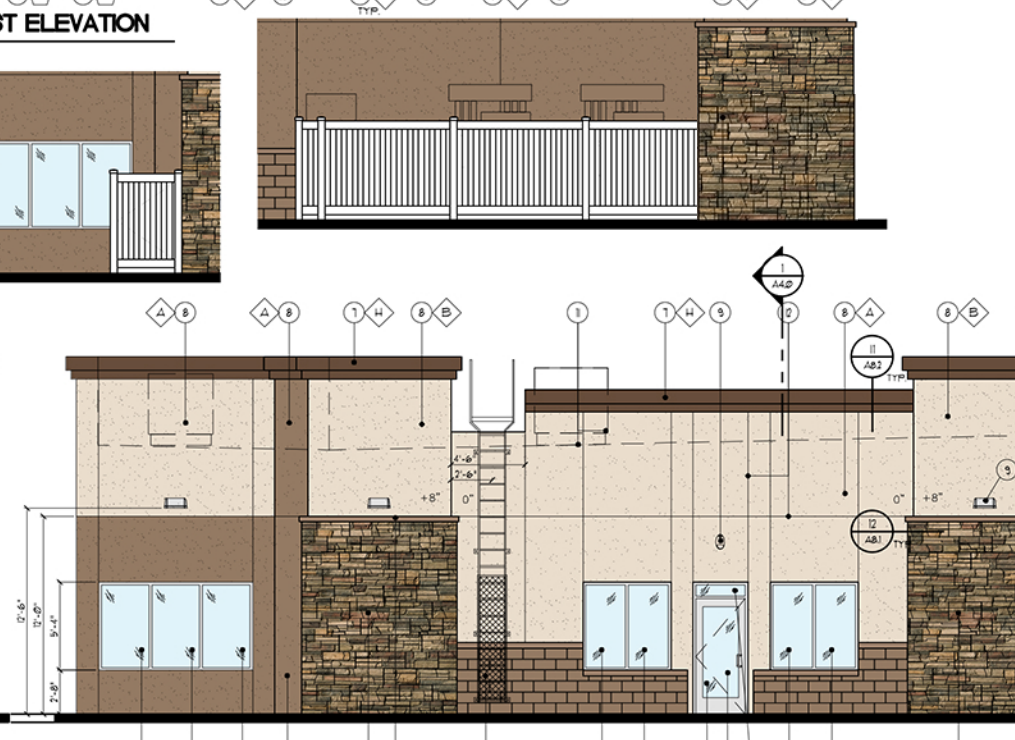

4 SOUTHWEST ELEVATION
SCALE: 3/16" = 1'-0"

WALL AREA & GLAZING AREA:
WALL AREA BETWEEN 3'-0" = 230 SQ FT
25% OF WALL AREA = 57.5 SQ FT
TOTAL GLAZING SQ FT = 60 SQ FT

KEY NOTES

1. STEEL COLUMN WRAP WITH METAL BREAK
2. LINE OF CANOPY / SOFFIT
3. CLEAR ANODIZED FRAME W/ CLEAR GLASS WINDOW SYSTEM
4. INTERNALLY ILLUMINATED SIGN (UNDER SEPARATE PERMIT)
5. CLEAR ANODIZED FRAME W/ CLEAR GLASS STOREFRONT SYSTEM
6. SERVICE DOOR PAINT TO MATCH SURROUNDING WALL
7. FIRESTONE ANCHORAGE FASCIA
8. PAINTED CEMENTITIOUS FINISH WITH ACRYLIC FINISH APPLIED PER MFG. SPECS. MIN. 1/4" DIRECT APPLIED OVER CMU 4 MIN. 3/4" W/ WIRE LATH OVER 2 LAYERS OF 5 LBS BUILDING PAPER OVER 3/8" GRADE PLUWOOD OVER METAL STUDS.
9. WALL MOUNTED LIGHT FIXTURE SEE ELECTRICAL PLAN
10. PANEL LOCATION SEE ELECTRICAL PLAN
11. ROOF LINE AND HVAC UNITS
12. STUCCO EXPANSION JOINT WITH FRY REGLET PCB-319-50 SEE DETAIL 44 & 48(A&B)
13. ROOF LADDER WITH SECURITY GATE
14. ADDRESSING LOCATION: 8" TALL, NCH BLACK NUMBERS. FINAL AREA LOCATION TO BE DETERMINED BY FIRE DEPARTMENT.
15. 4x8x6 CMU VENEER, SPLIT FACE, GROUTED TO MATCH CMU COLOR
16. 4x4x8 SOLID CMU CAP INSTALL PER MFG. SPECS.
17. STUCCO SCORE LINE WITH FRY REGLET. SEE DETAILS 1(A&B)
18. PARAPET WALL BEYOND
19. NOT USED
20. SPOCKED GLASS OR BLACK OUT GLASS
21. STONE VENEER INSTALL PER MFG. SPECS. INSTALL GROUTED. GROUT TO MATCH STONE COLOR.
22. OVERFLOW ROOF GUTTER SEE DETAIL 5(A1)
23. FOAM BLAND
24. STONE VENEER CAP, INSTALL PER MFG. SPECS
25. COS TANK
26. EXTERIOR FINISH TO EXTEND ABOVE SIDEWALK GRADE. SEE DET. 1(A&B)

FINISH SCHEDULE

- A - SHERWIN WILLIAMS 6095 - TOASTY
 - B - SHERWIN WILLIAMS 6015 - TOTALLY TAN
 - C - CLEAR GLASS 0.8 (MAX. U-FACTOR & 4 MAX. SHGC 42)
 - D - SHERWIN WILLIAMS H-5010 POLYURETHANE - SAFETY RED - CIRCLE K RED
 - E - SHERWIN WILLIAMS 1009 - CIRCLE K WHITE
 - F - 41 BLOCK SPLITFACE CMU OR EQUAL - 8-12"
 - G - CULTURED STONE CSV 10006 - CHARDONNAY COUNTRY LEDGESTONE BY QUENS CORNING/BORAL
 - H - SHERWIN WILLIAMS 6090 - JAVA
 - I - CIRCLE K ORANGE 9915 144
- *USE SHERWIN WILLIAMS MANUFACTURER ONLY.

CITY APPROVAL STAMP



CIRCLE K STORES, INC.
SOUTH ATLANTIC
215 PENDLETON STREET
WAYCROSS, GA 31501
912-490-2327
912-490-1087 fax

DESIGN TEAM:
Hartley + Purdy
Architecture, Inc.
1711 North Himes Avenue, Tampa, Florida 33607
Ph 813533-0035 Fax 813533-4350 Web Site: www.hartleypurdy.com
AA-0003276

NO.	DATE	REVISION DESCRIPTION

SCOTT J. PURDY
AR 31576

**5495 SQ. FT.
CMU BUILDING
A.K.A. 4968**

SITE DESIGNATIONS:
**PROPOSED CIRCLE K STORE
SEC OF NW 13th STREET
& NW 6th STREET
GAINESVILLE, FL 32609**

SCALE: AS NOTED H+P JOB # 1903.02

DATE: 11.17.2020

DESIGNED BY: [Signature]

DRAWN BY: CWS FILE NAME:

CHECKED BY: SJP

DRAWING TITLE:

EXTERIOR ELEVATIONS

SHEET NO. **A2.1**